

NOTE:
OFFAL AND HIDE ROOMS MAY BE ON SAME LEVEL OR LOWERED, DEPENDING ON TERRAIN.

NOTE:
CHECK ROOF REQUIREMENTS WITH STATE OR FEDERAL INSPECTOR. IF ROOF IS REQUIRED, EXTEND 6"x6" POSTS AND ADD PLATE TO SUPPORT TRUSS ROOF. LEAVE RIDGE OPENING FOR VENT.

DESIGN CAPACITY = 10 HEAD PER DAY

NOTE:
ADD COVERED LOADING AREA, AS REQ'D.

FLOOR PLAN
SCALE: 3/16" = 1'-0"
12" 0' 1' 2' 3' 4'


NOTES:
THE PURPOSE OF THESE PLANS IS TO SERVE AS A GUIDE ONLY. FOR A PLANT TO BE ELIGIBLE FOR OFFICIAL INSPECTION, DETAILED PLANS MUST BE SUBMITTED TO YOUR LOCAL HEALTH & BUILDING CODE AUTHORITIES, FOR APPROVAL BEFORE CONSTRUCTION IS BEGUN.

BASED ON: VPI & SU PLAN NO. M-1.76

COOPERATIVE EXTENSION WORK IN
AGRICULTURE AND HOME ECONOMICS
STATE OF MISSISSIPPI
MISSISSIPPI STATE UNIVERSITY
AND
UNITED STATES DEPARTMENT OF AGRICULTURE COOPERATING


CUSTOM SLAUGHTERHOUSE

VA '77 6270 SHEET 1 OF 4

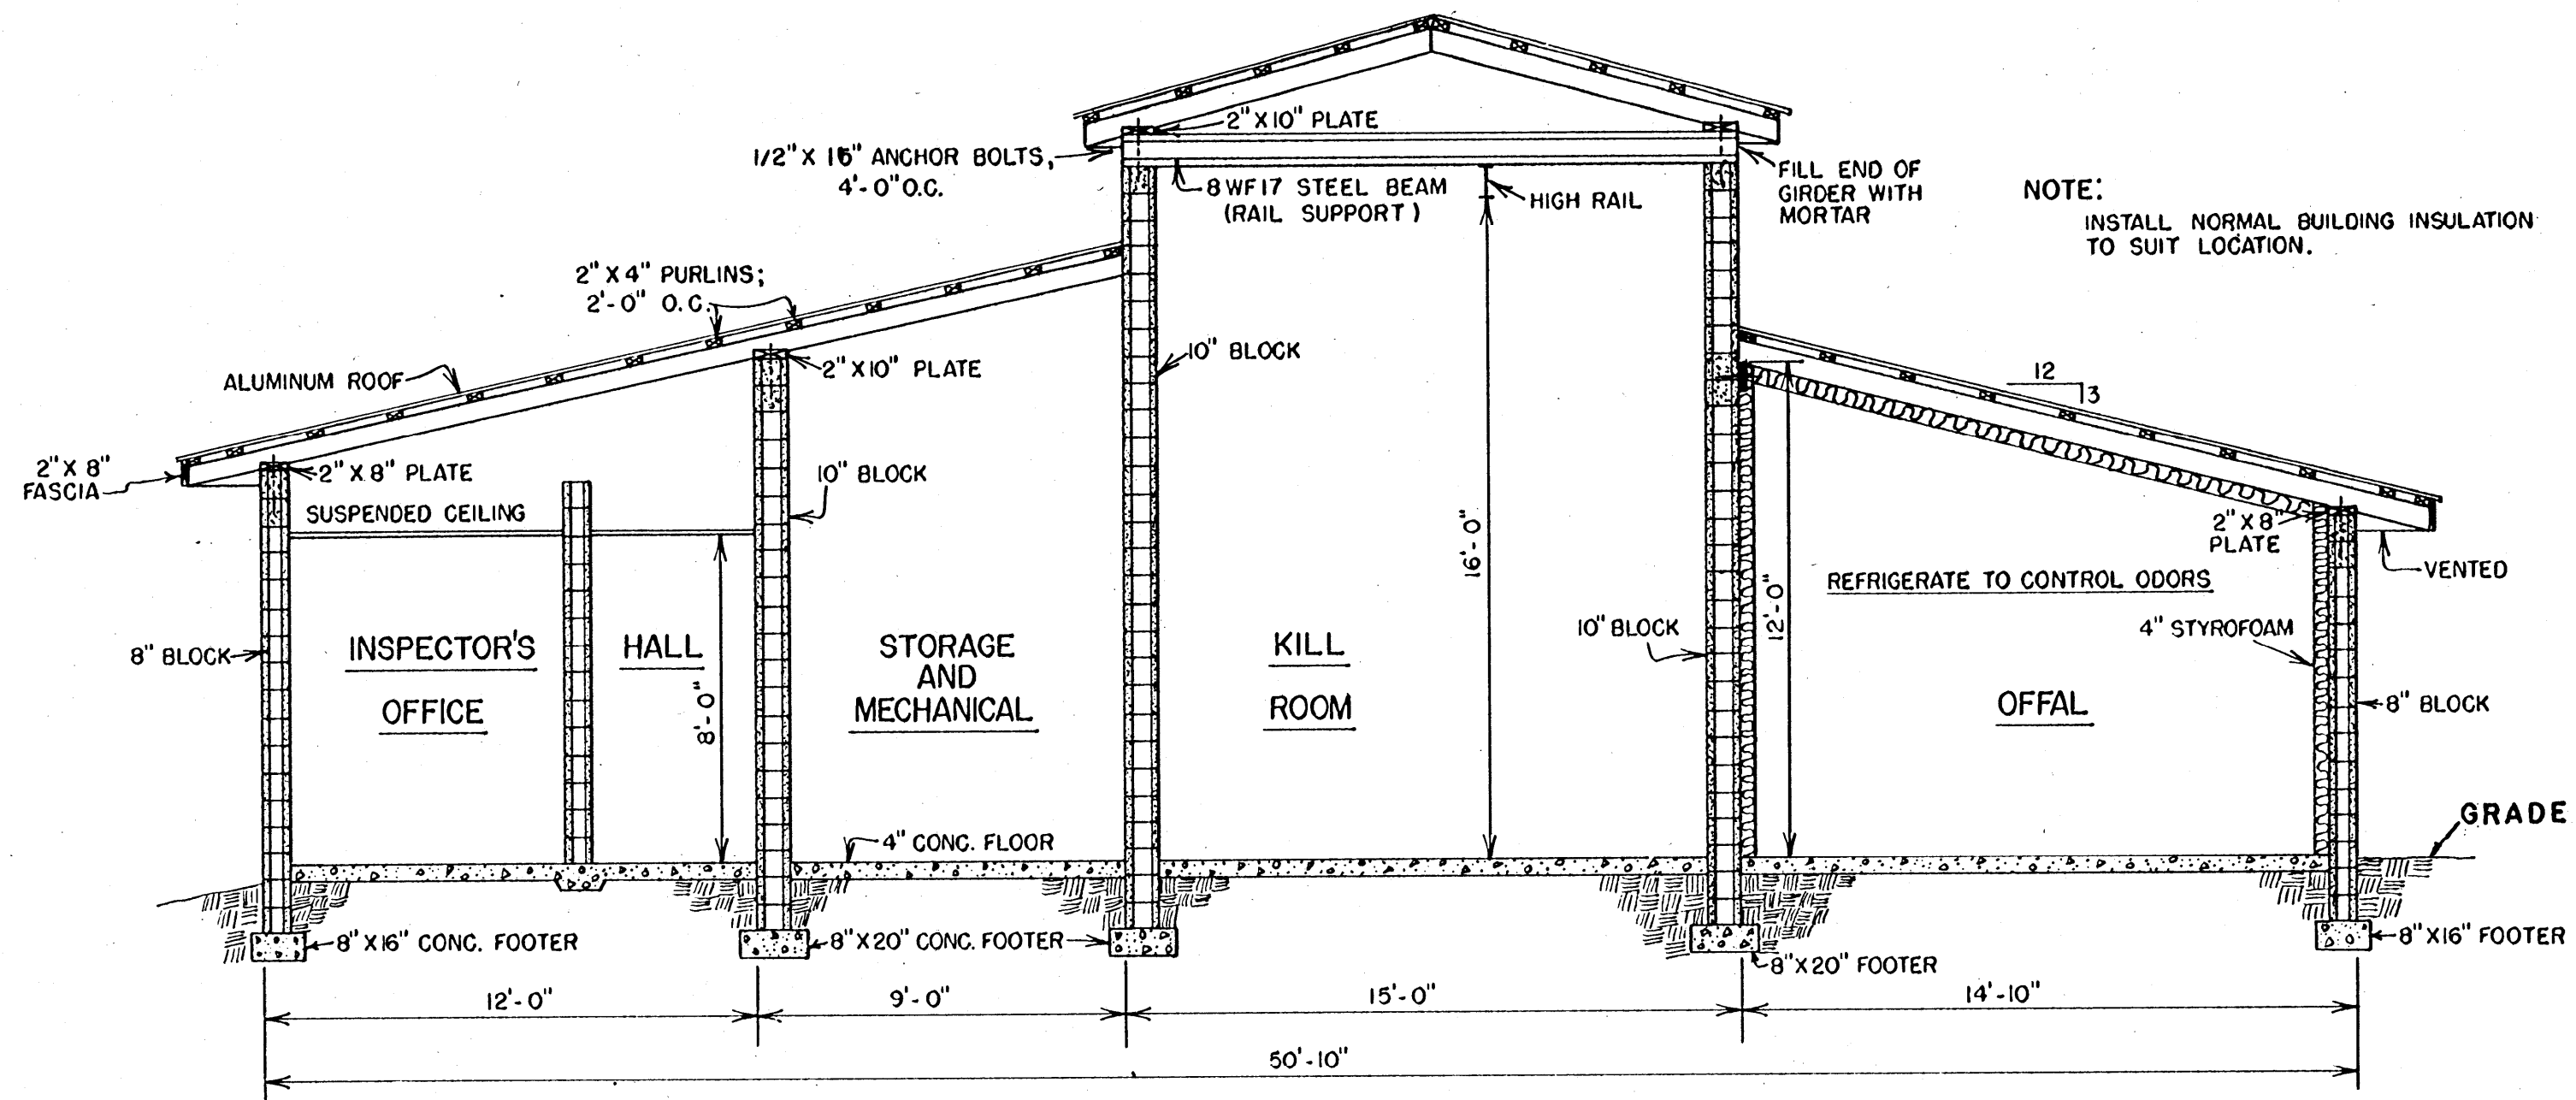


SECTION A-A
SCALE: 1/4"=1'-0"

EXTEND FOOTINGS TO FIRM BASE
BELOW FROST LINE

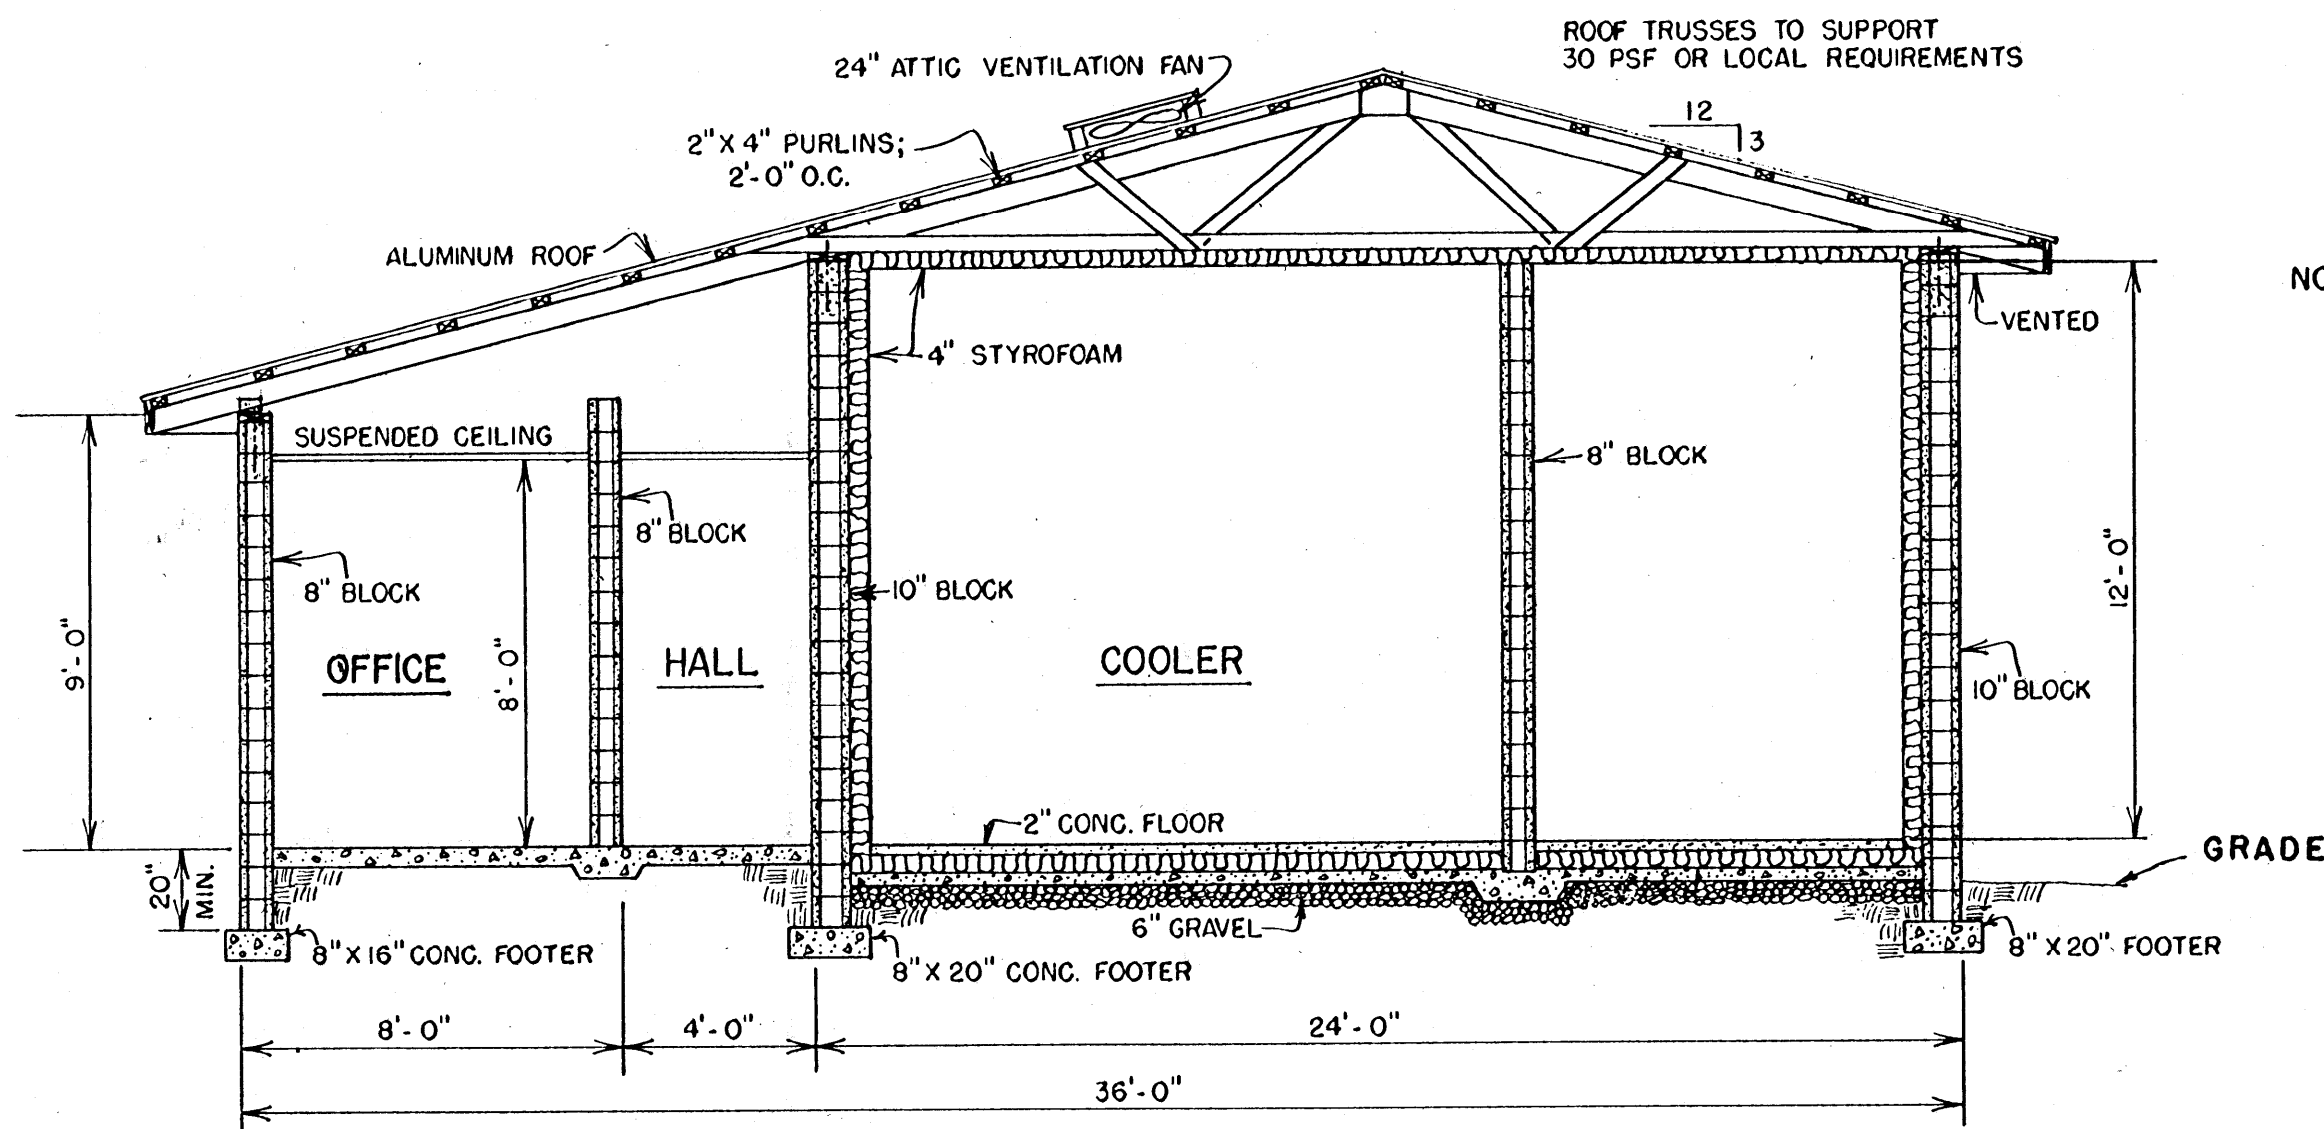


SECTION B-B
SCALE: 1/4"=1'-0"

 


COOPERATIVE EXTENSION WORK IN
AGRICULTURE AND HOME ECONOMICS
STATE OF MISSISSIPPI
MISSISSIPPI STATE UNIVERSITY
AND
UNITED STATES DEPARTMENT OF AGRICULTURE COOPERATING

CUSTOM SLAUGHTERHOUSE


VA '77 6270 SHEET 2 OF 4

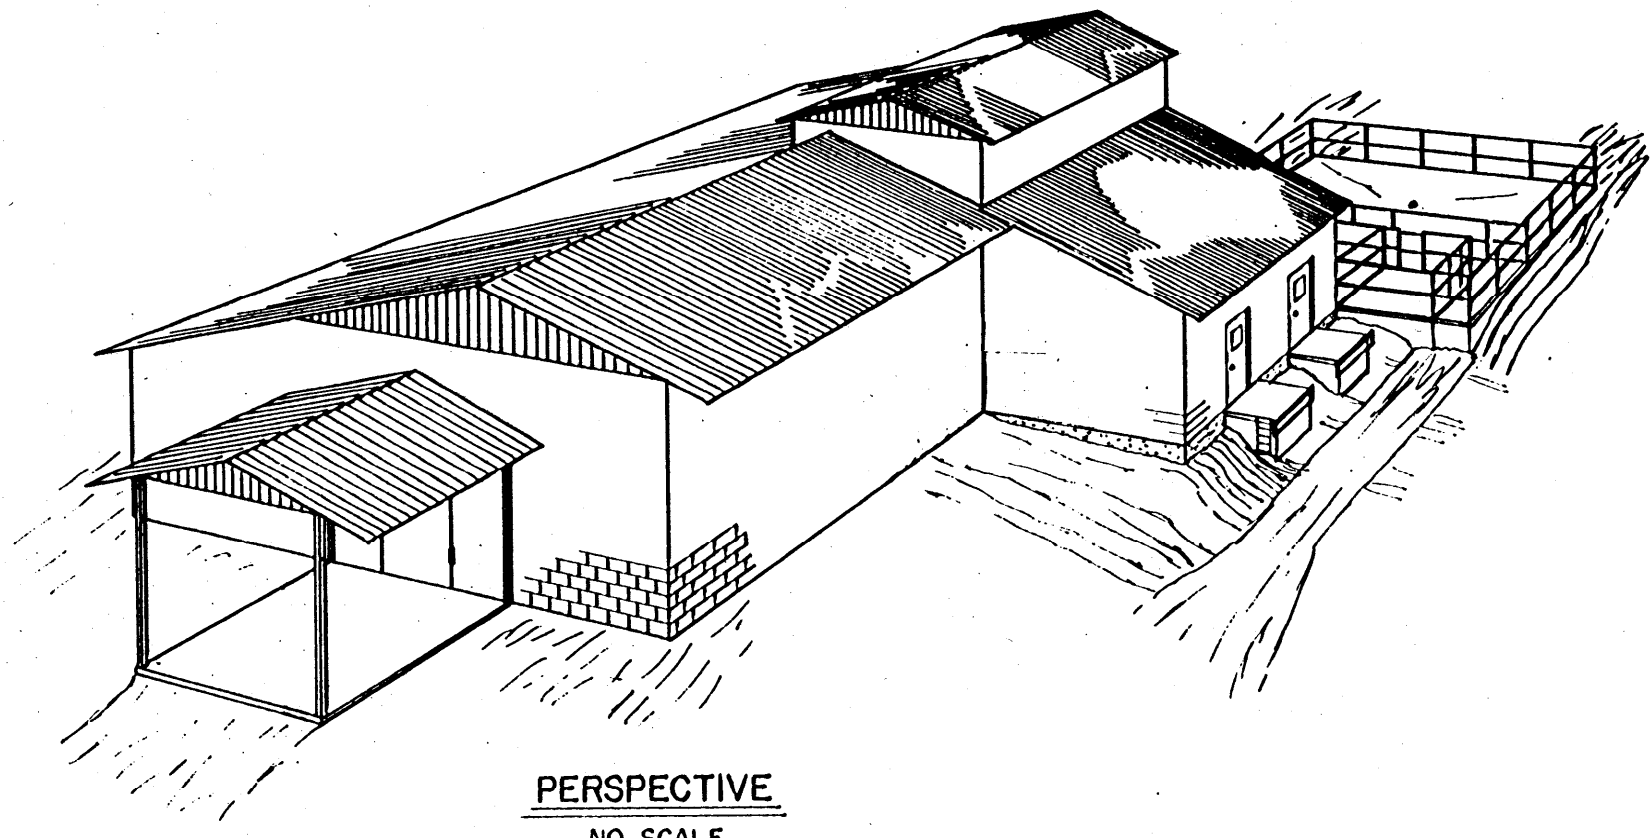


PERSPECTIVE
NO SCALE

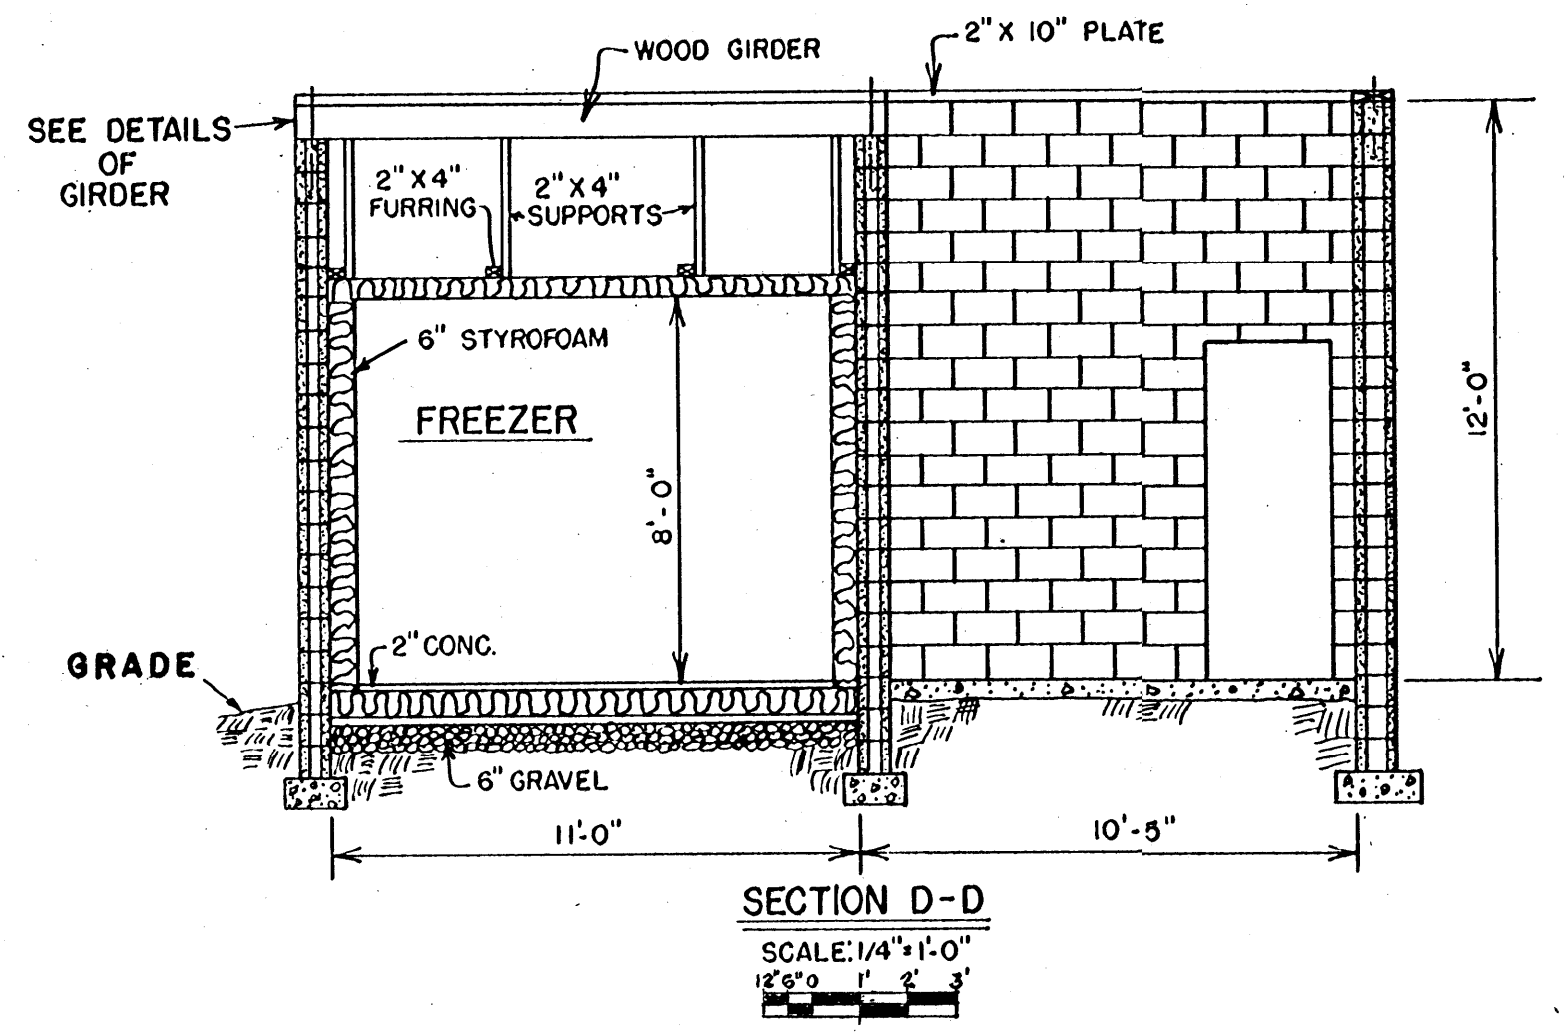


SECTION D-D
SCALE: 1/4" = 1'-0"
12'-0" 1' 2' 3"

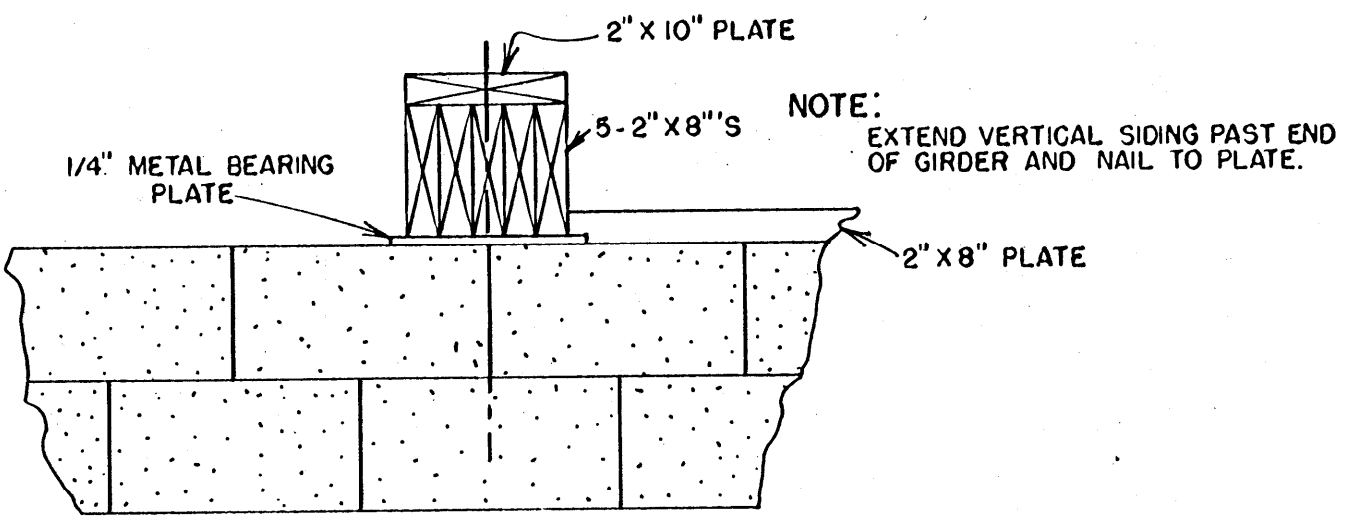

DETAIL OF OUTSIDE
END OF GIRDER

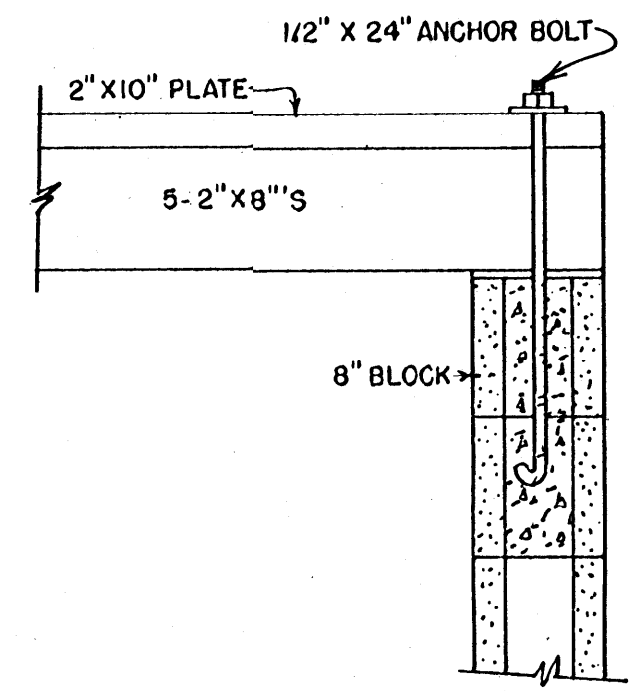

DETAIL OF INSIDE
END OF GIRDER

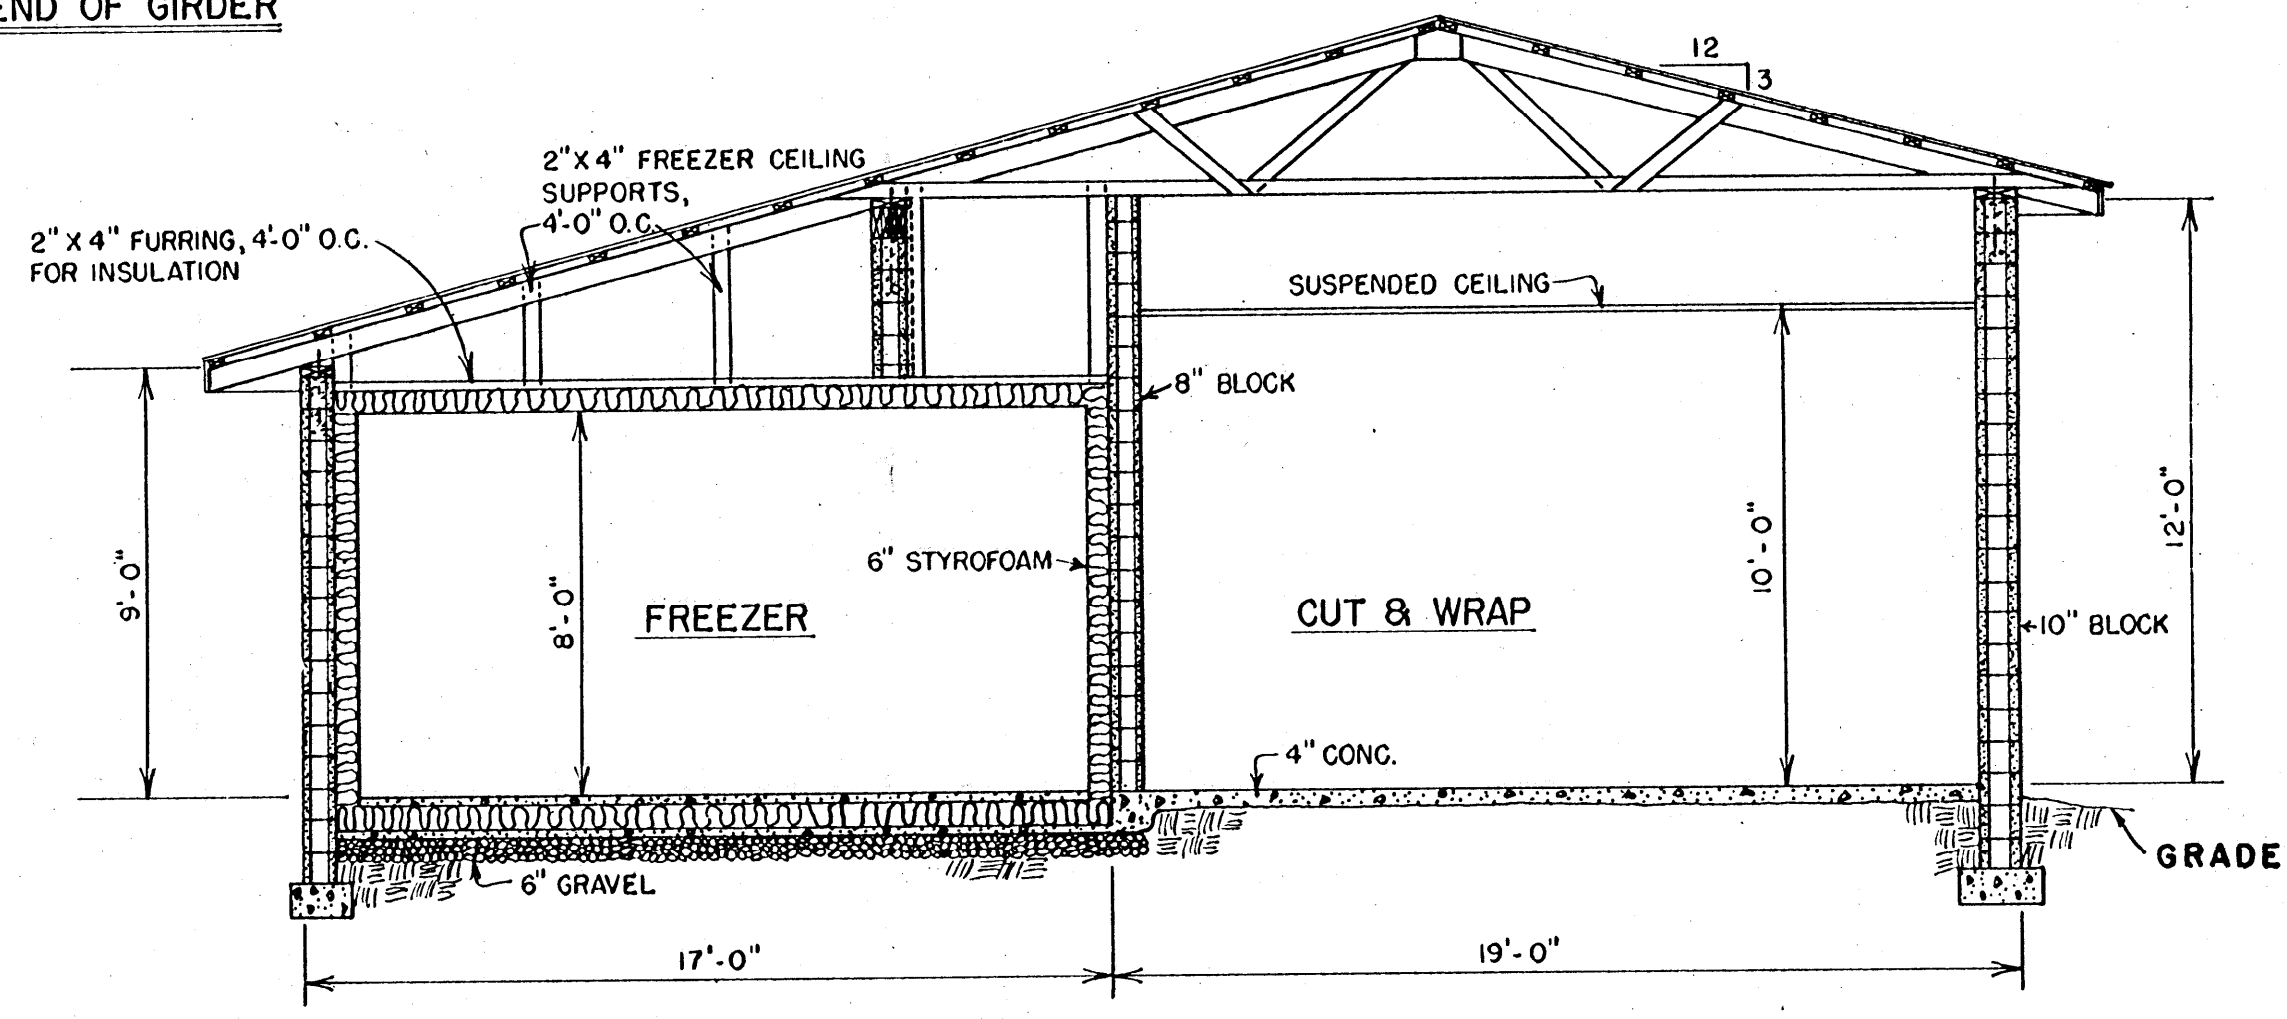

SECTION C-C
SCALE: 1/4" = 1'-0"
12'-0" 1' 2' 3"

EXTEND FOOTINGS TO FIRM BASE
BELOW FROST LINE



 

 

 
 
SCALE: 1" = 1'-0" UNLESS
OTHERWISE NOTED.
12' 9" 6" 3" 0"


COOPERATIVE EXTENSION WORK IN
AGRICULTURE AND HOME ECONOMICS
STATE OF MISSISSIPPI
MISSISSIPPI STATE UNIVERSITY
AND
UNITED STATES DEPARTMENT OF AGRICULTURE COOPERATING

CUSTOM SLAUGHTERHOUSE


VA '77 6270 SHEET 3 OF 4

NOTE:
HANG LIGHTS FROM CABLES IF
HOLDING AREA IS OPEN

ELECTRICAL SYMBOLS	
	CEILING OUTLET W/INCADESCENT FIXTURE
	CEILING OUTLET W/FLOURESCENT FIXTURE
	FLOURESCENT FIXTURE IN CONTINUOUS ROW
	RECEPTACLE OUTLET. DUPLEX GROUNDING TYPE
	INDICATES SWITCH CONTROL
	LOCAL SWITCH, SINGLE POLE
	LOCAL SWITCH, 3 WAY
	ELECTRIC BASEBOARD HEATER

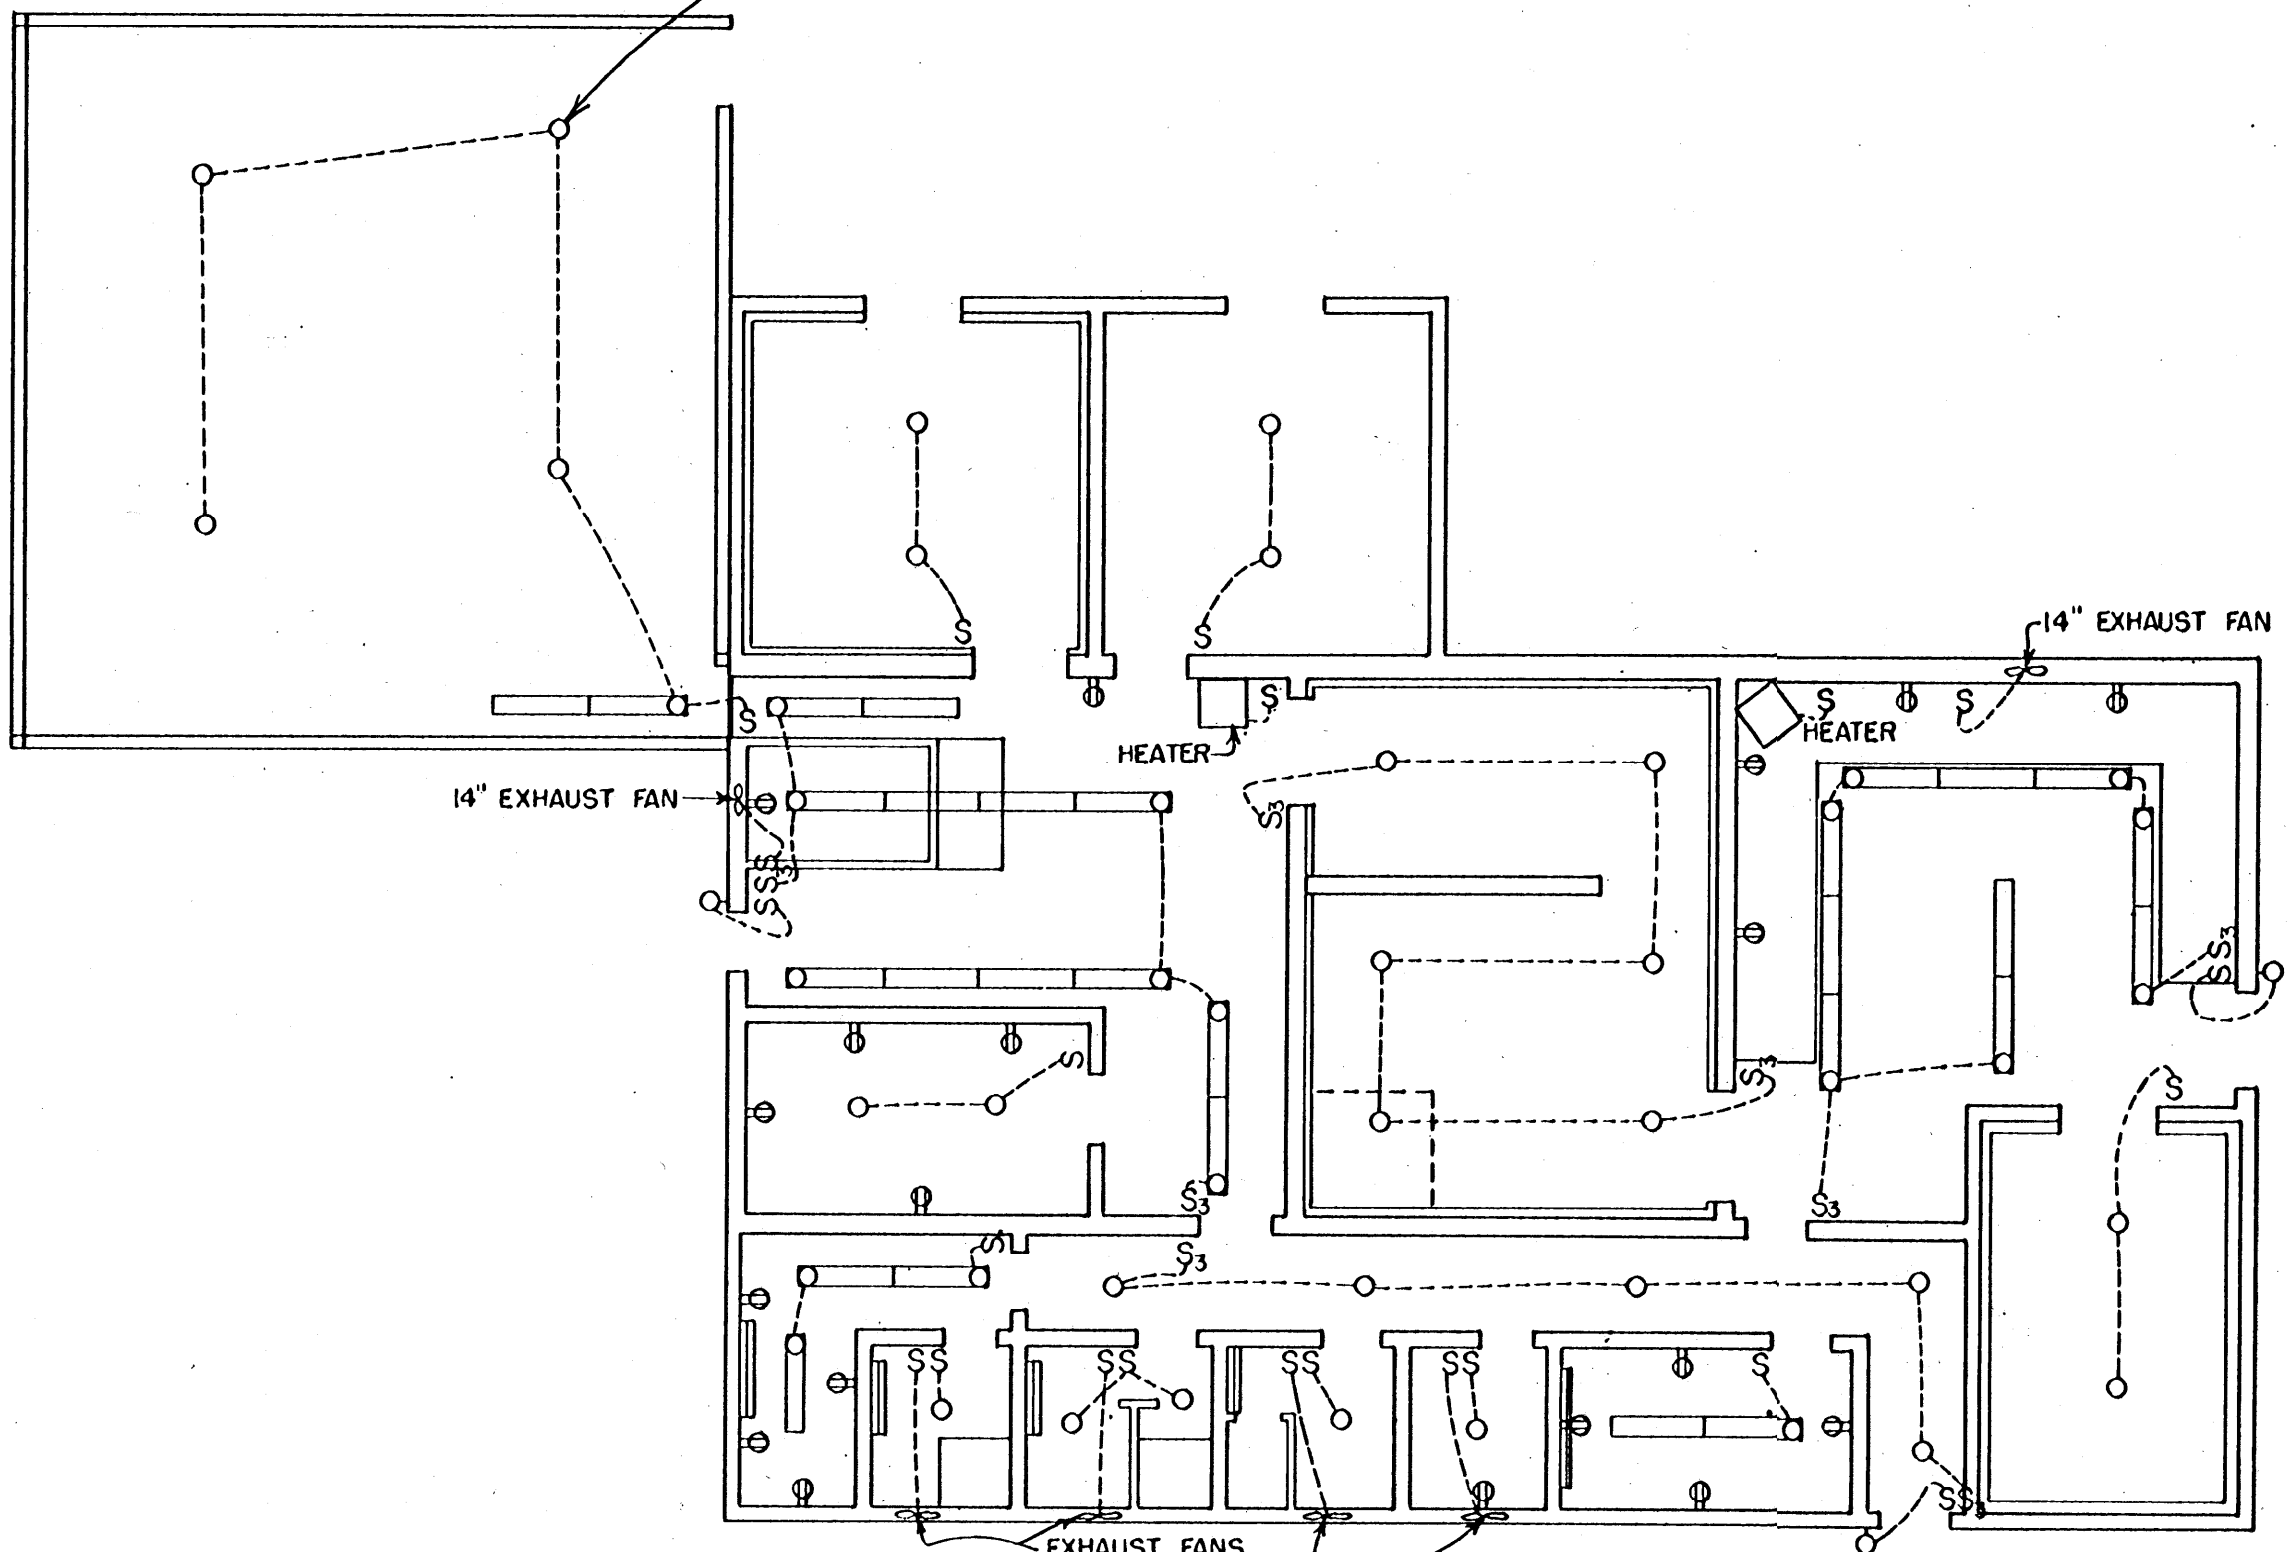

ELECTRICAL LAYOUT

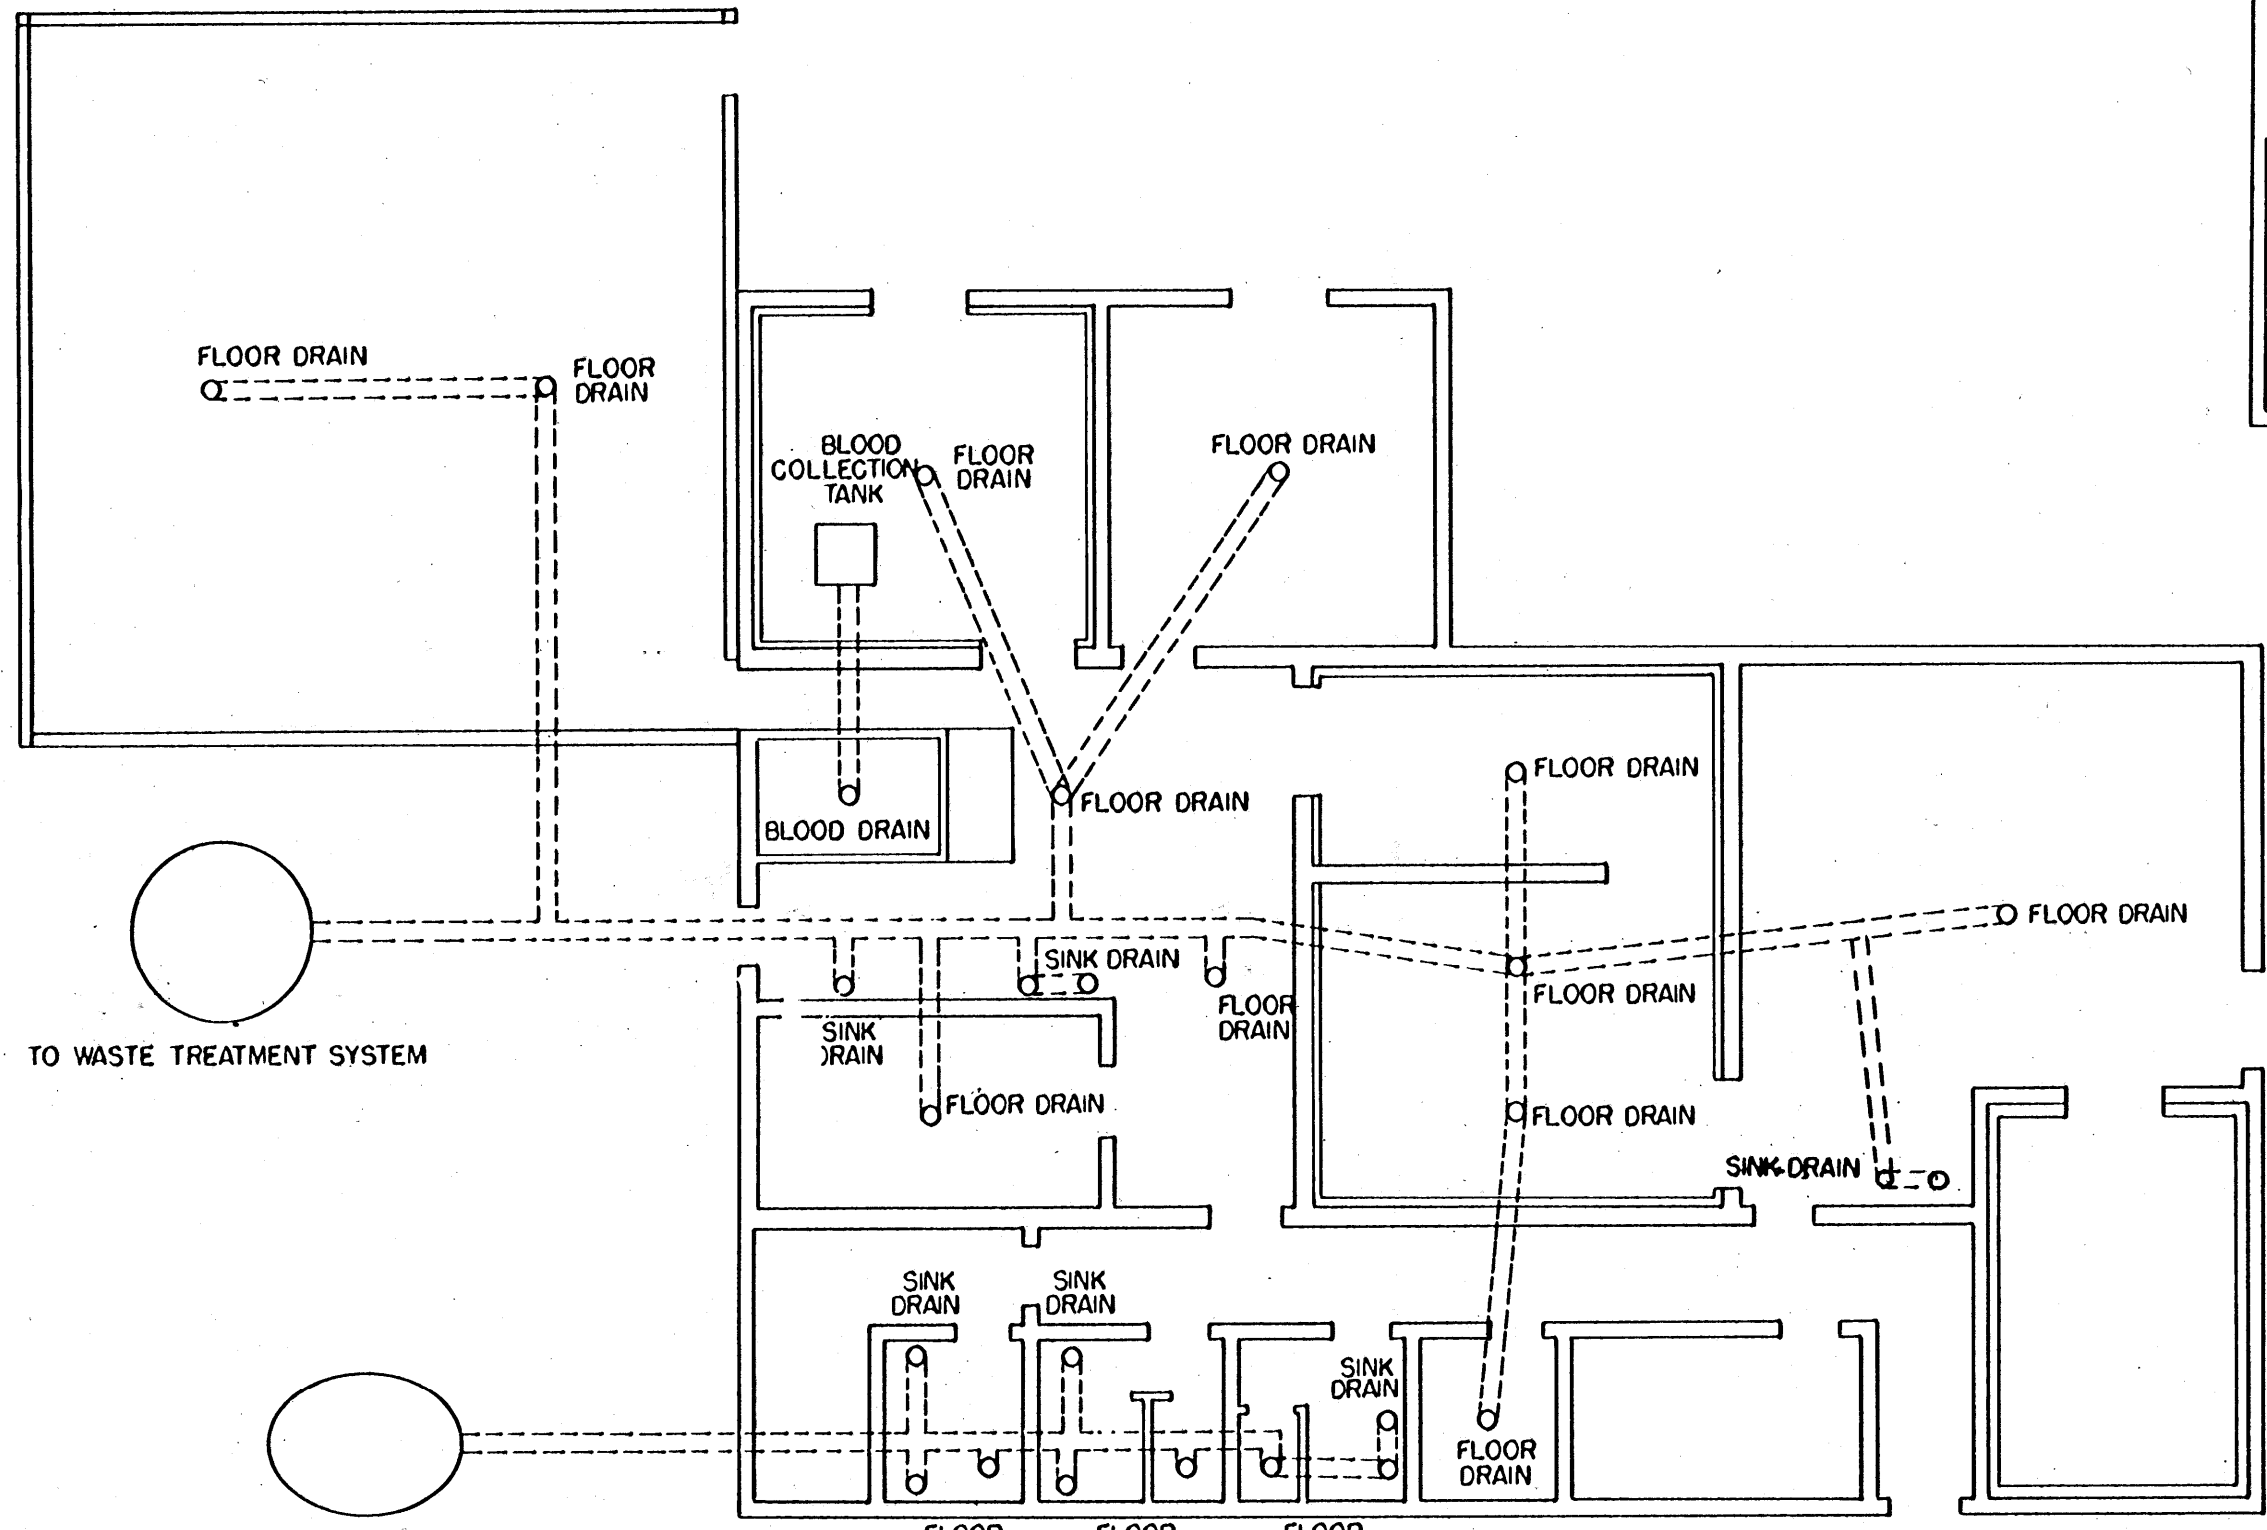

DRAIN SYSTEMS

NOTE:
ALL DRAINS TO BE EQUIPPED WITH
A DEEP SEAL TRAP & PROPERLY
VENTED. USE RODENT SCREENS
WHERE NECESSARY.

12' 0" 4' 8"
SCALE: 1/8" = 1'-0" UNLESS
OTHERWISE NOTED.

COOPERATIVE EXTENSION WORK IN
AGRICULTURE AND HOME ECONOMICS
STATE OF MISSISSIPPI
MISSISSIPPI STATE UNIVERSITY
AND
UNITED STATES DEPARTMENT OF AGRICULTURE COOPERATING

CUSTOM SLAUGHTERHOUSE

VA	'77	6270	SHEET 4 OF 4
----	-----	------	--------------